


DRAWN ONLY

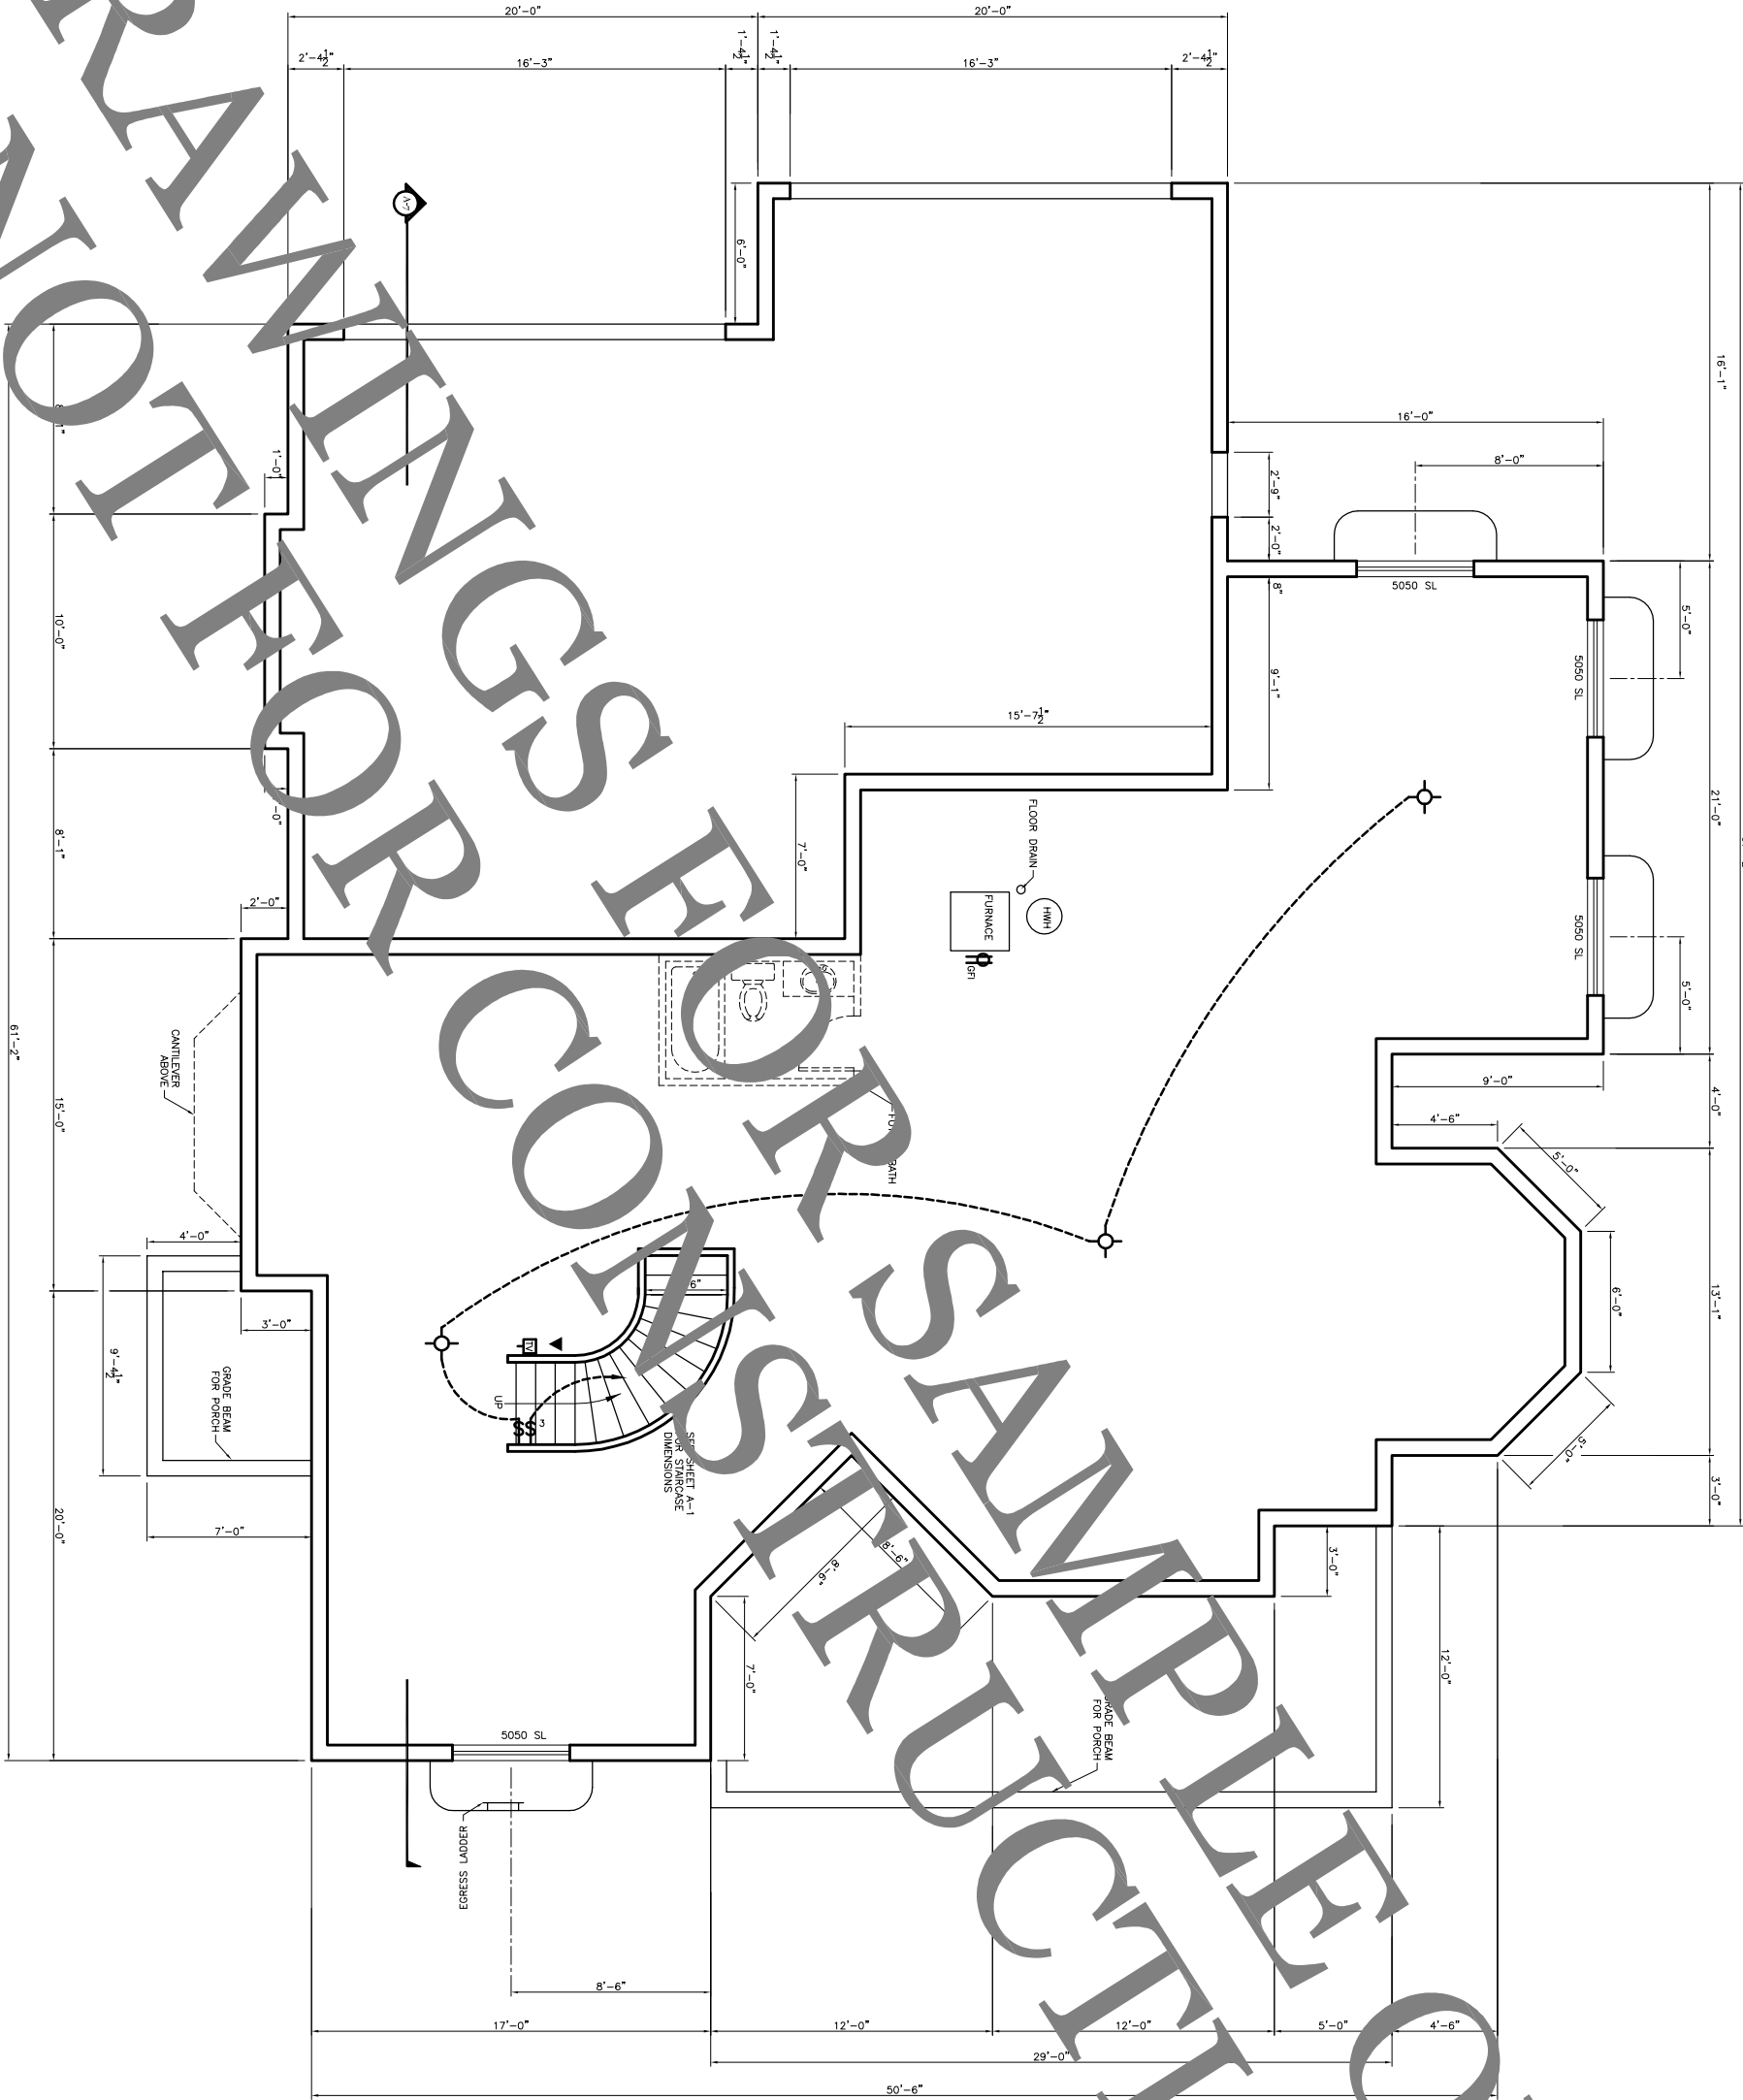

BASEMENT PLAN

ELECTRICAL LEGEND	
	SURFACE MOUNTED LIGHT
	3-WAY SWITCH
	SINGLE POLE SWITCH
	GROUND FAULT INTERRUPT
	PHONE JACK
	T.V. JACK

DRAWN BY: _____
 PLANNING DATE: _____
 SCALE: 1/4" = 1'-0"
 SHEET NO. **A-3**

REVISION	DATE

MODEL #3536

**HOUSE PLAN
BROKER.COM**
 Specializing In Computer Designed House Plans
www.houseplanbroker.com